


LEGEND OF SYMBOLS:


● Z1 ISARO PRO - 36 3000K EWR OPTIC

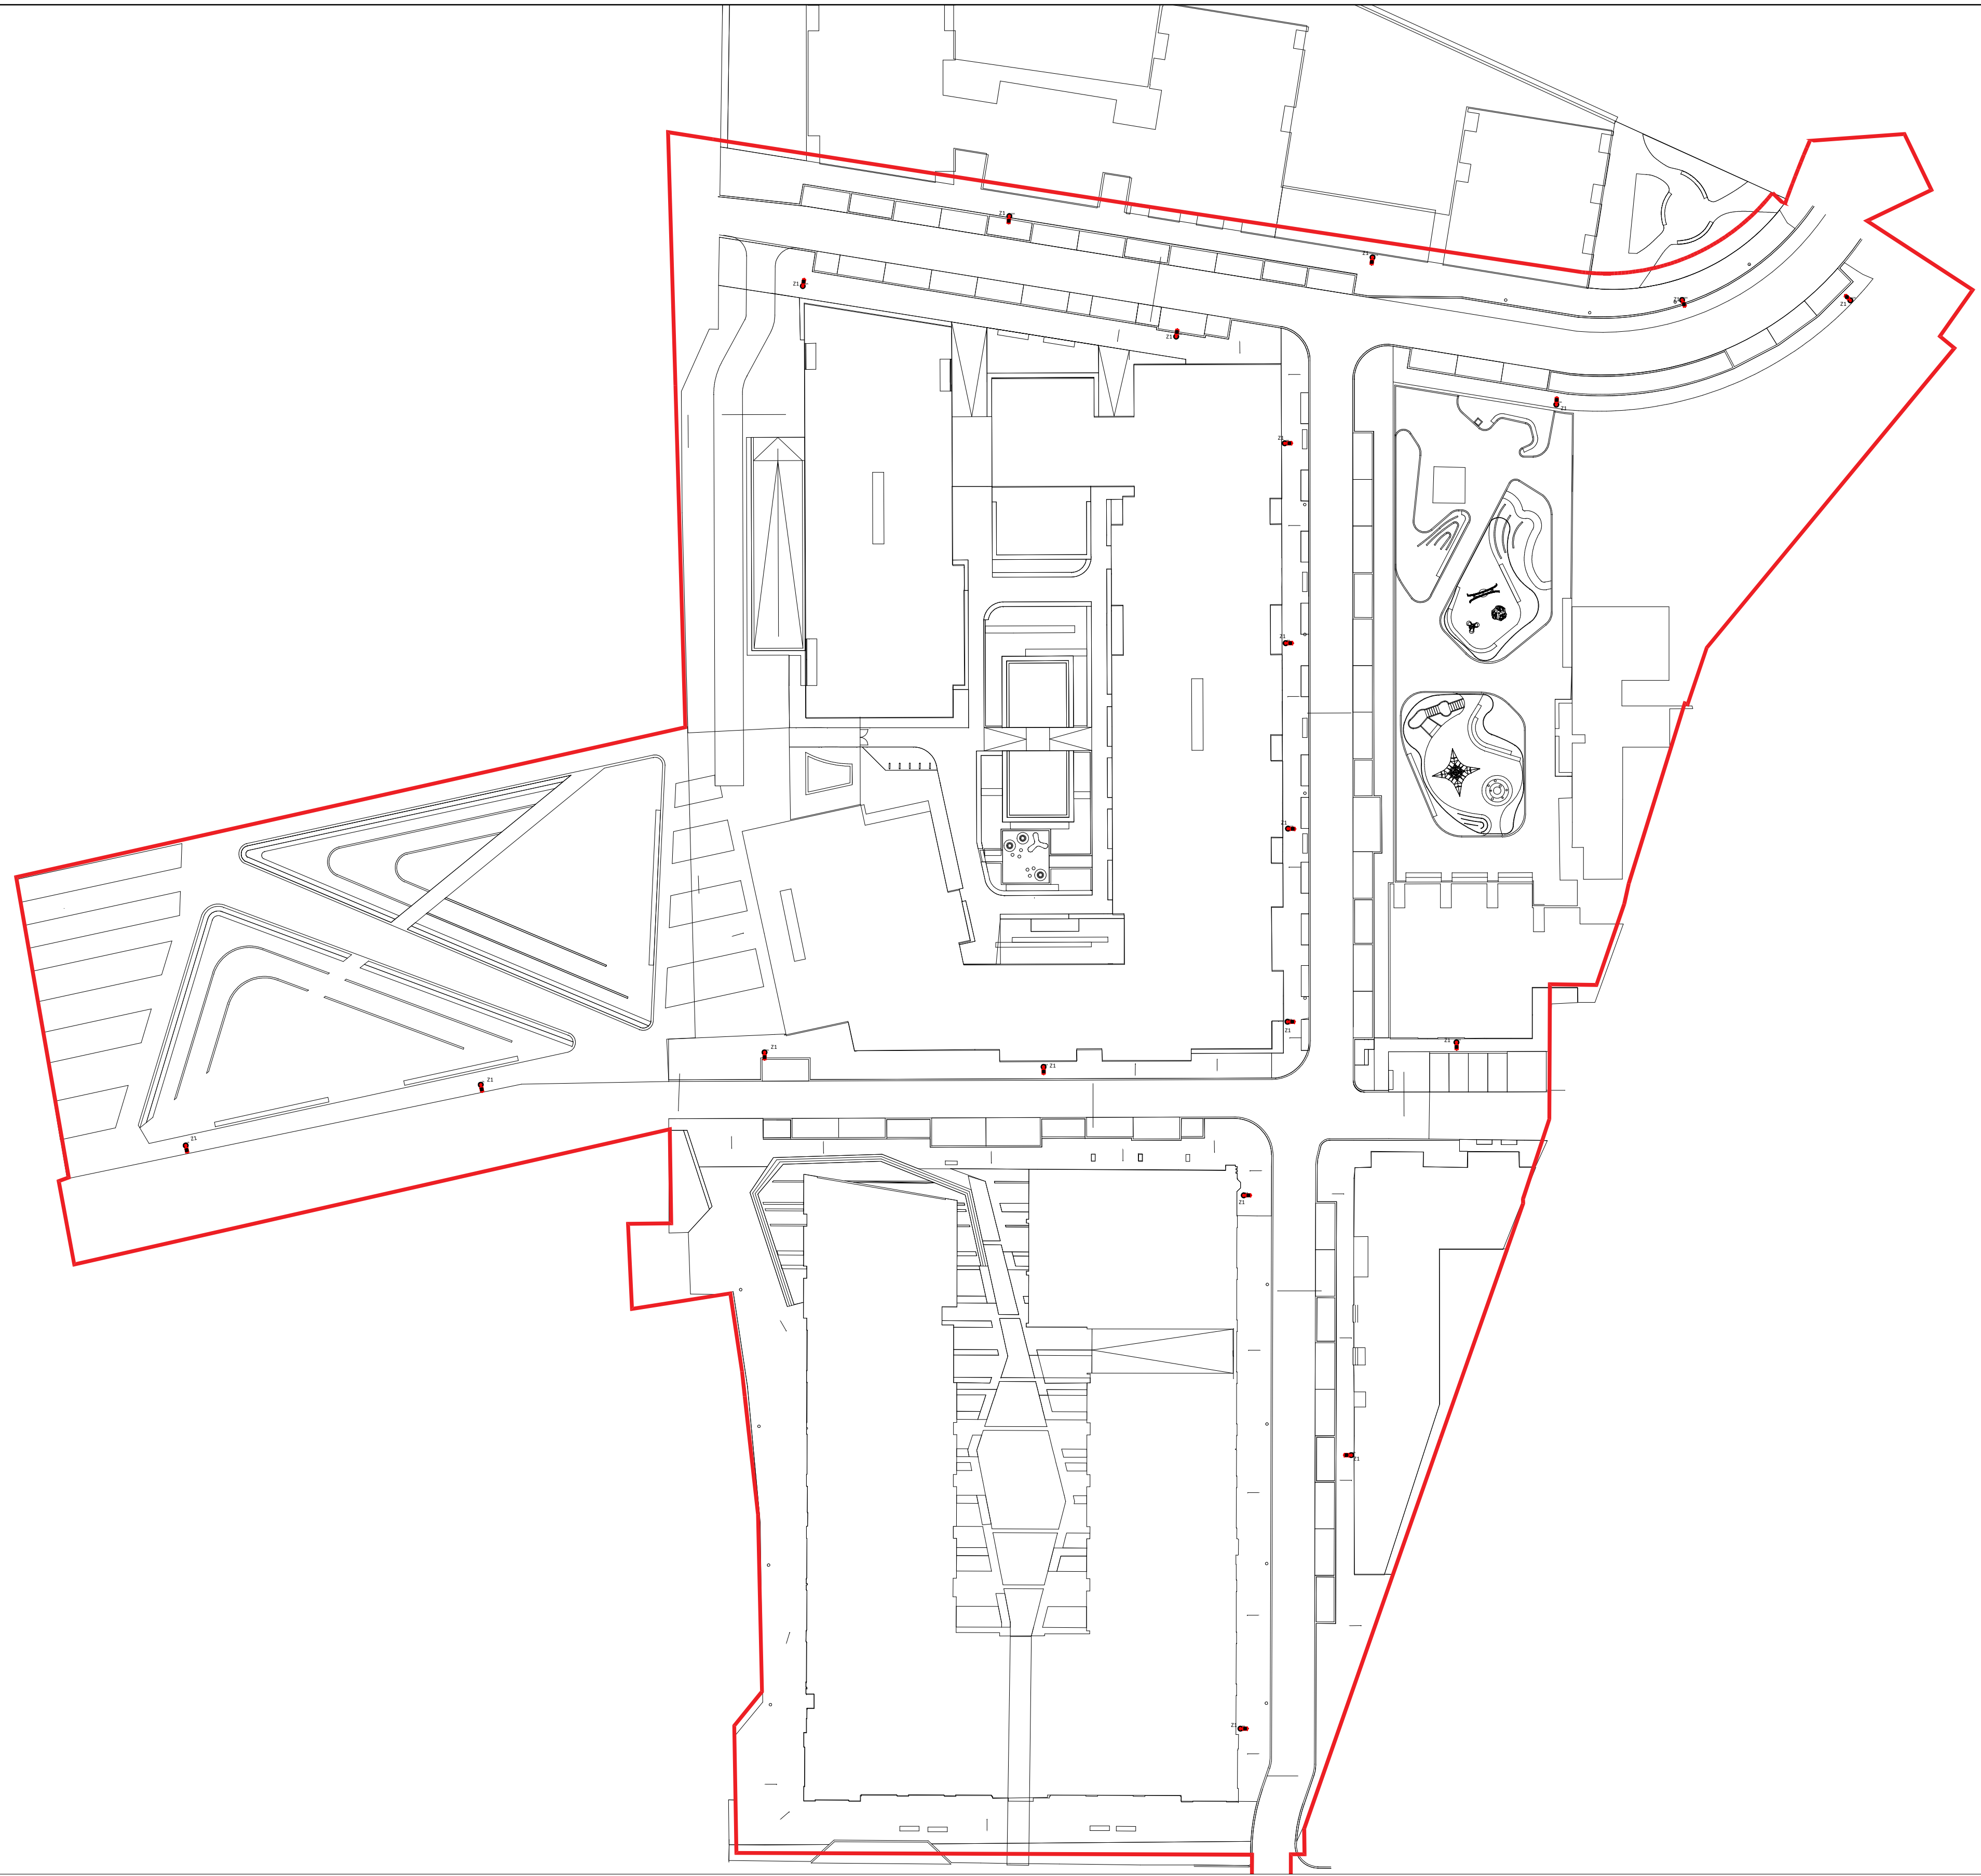

- FOR SETTING OUT REFER TO ARCHITECT'S DRAWINGS.
- THIS DRAWING TO BE READ IN CONJUNCTION WITH ALL OTHER ARCHITECTURAL AND ENGINEERING DRAWINGS AND ALL OTHER RELEVANT DRAWINGS AND SPECIFICATIONS.
- DO NOT SCALE THIS DRAWING. USE FIGURED DIMENSIONS ONLY.
- NO PART OF THIS DOCUMENT MAY BE REPRODUCED OR TRANSMITTED IN ANY FORM OR STORED IN ANY RETRIEVAL SYSTEM OF ANY NATURE WITHOUT THE WRITTEN PERMISSION OF O'CONNOR SUTTON CRONIN AS COPYRIGHT HOLDER EXCEPT AS AGREED FOR USE ON THE PROJECT FOR WHICH THE DOCUMENT WAS ORIGINALLY ISSUED.

Rev No.	Date	Revision Note	Drn by	Chkd by
S8	11.03.20	ISSUED FOR PLANNING	B.O.B.	E.O.

Rev No.	Date	Revision Note	Drn by	Chkd by

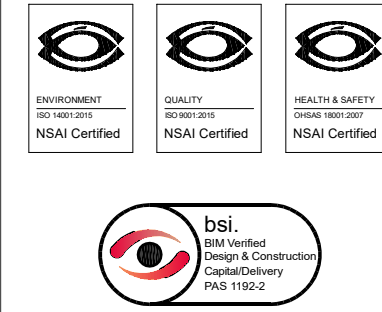

Head Office,  
9 Prussia Street,  
Dublin 7,  
D07 KT57

TEL +353 (0)1 8682000  
e: [contactus@ocsc.ie](mailto:contactus@ocsc.ie)  
w: [www.ocsc.ie](http://www.ocsc.ie)

Dublin | London | Belfast | Galway | Cork | Birmingham



Client: CWTC MULTI FAMILY ICAV  
Project: PLAYERS SQUARE  
PLAYER WILLS SITE  
Title: ELECTRICAL  
SITE LIGHTING LAYOUT  
GROUND FLOOR PLAN

Code	Originator	Zone	Level	Type	Role	Number	Status	Revision
PLA	OCSC	XX	00	DR	E	0001	S8	P01

Date: 10.02.20 Scale: 1:500 @ A1 Drn by: B.O.B. Chkd by: B.O.B. Aprvd by: E.O.